



PLUMBING SUB BASEMENT FLOOR PLAN  
SCALE: 1/8" = 1'-0"

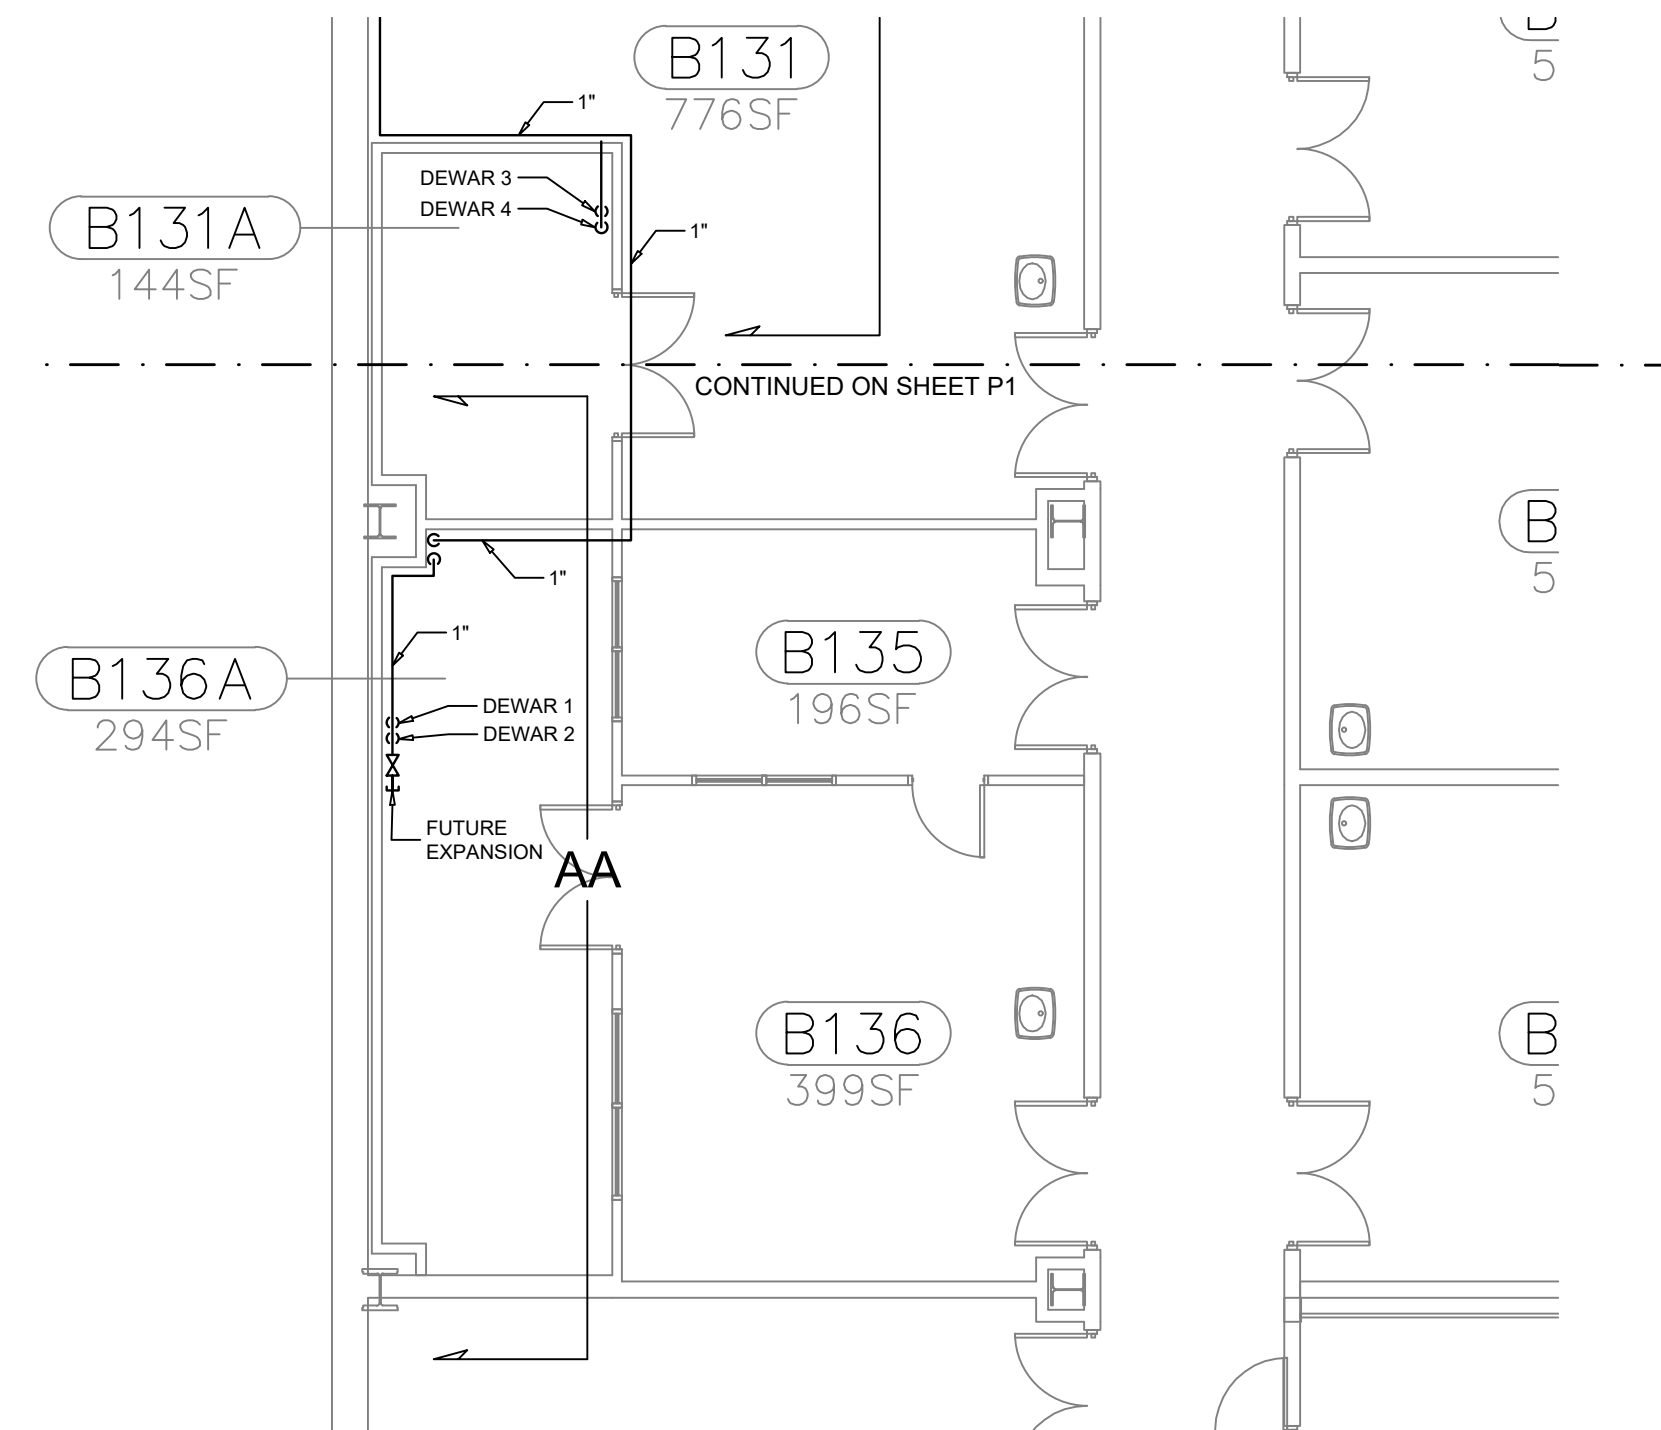

PLUMBING BASEMENT FLOOR PLAN  
SCALE: 1/8" = 1'-0"

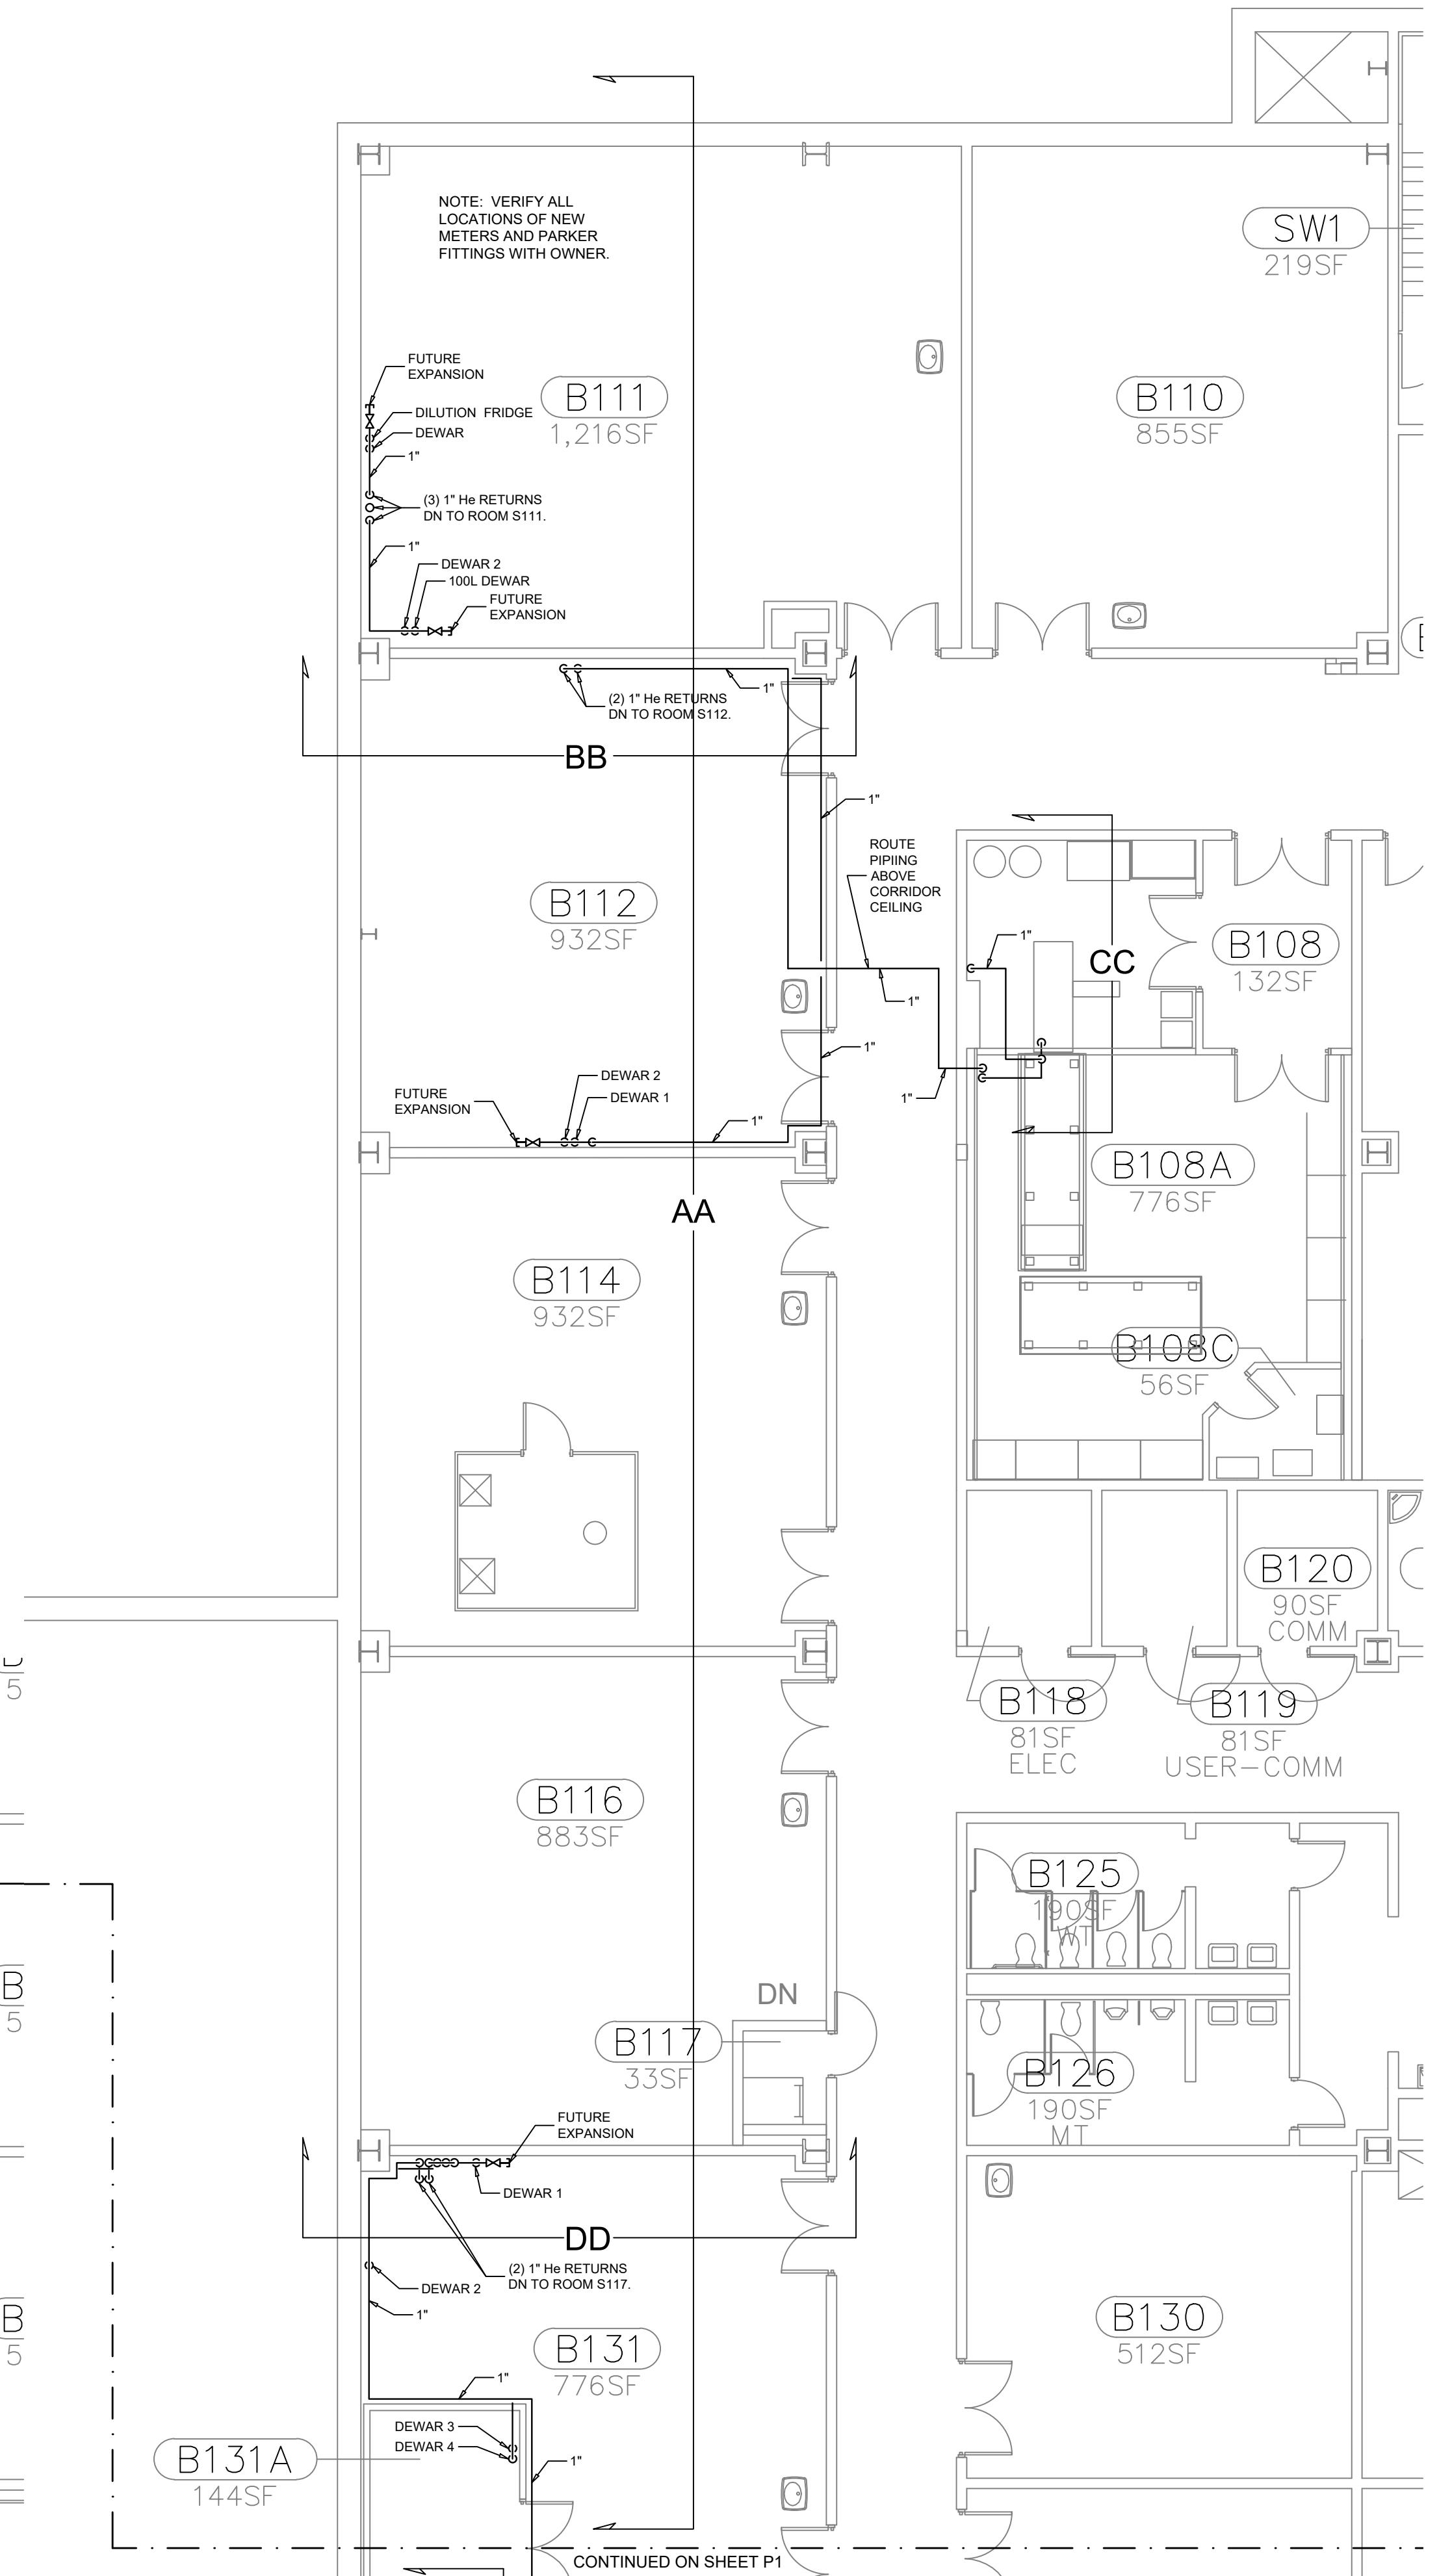

SCALE: 1/8" = 1'-0"

CAPITAL PROJ. NO. CP	
PR. MGR.	O'BRIEN
ARCH.	GOERGE
MECH.	
ELEC.	
CIVIL	
L.A.	
INT. DES.	
CONST. REP.	
APPR.	
DATE	12/5/2019
SCALE	AS NOTED
REVISIONS	