




ELEVATION AA
SCALE: 1/8" = 1'-0"

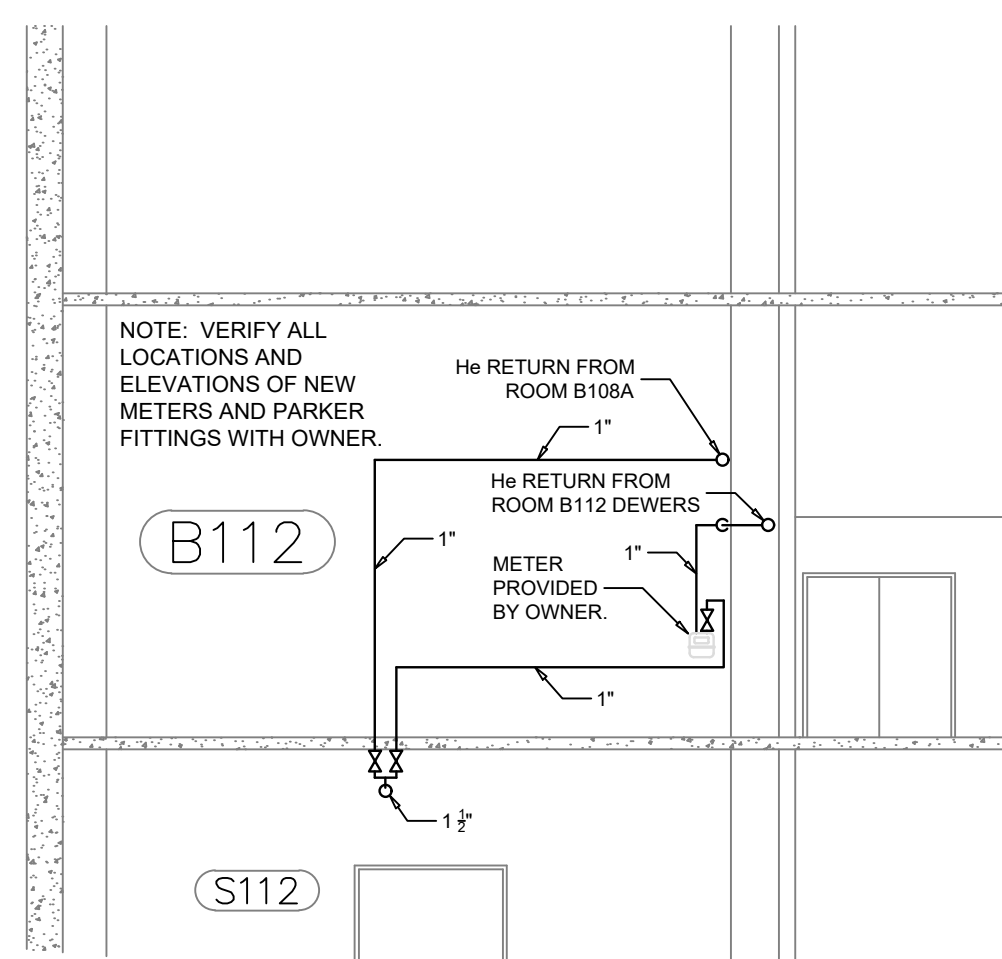

ELEVATION BB
SCALE: 1/8" = 1'-0"

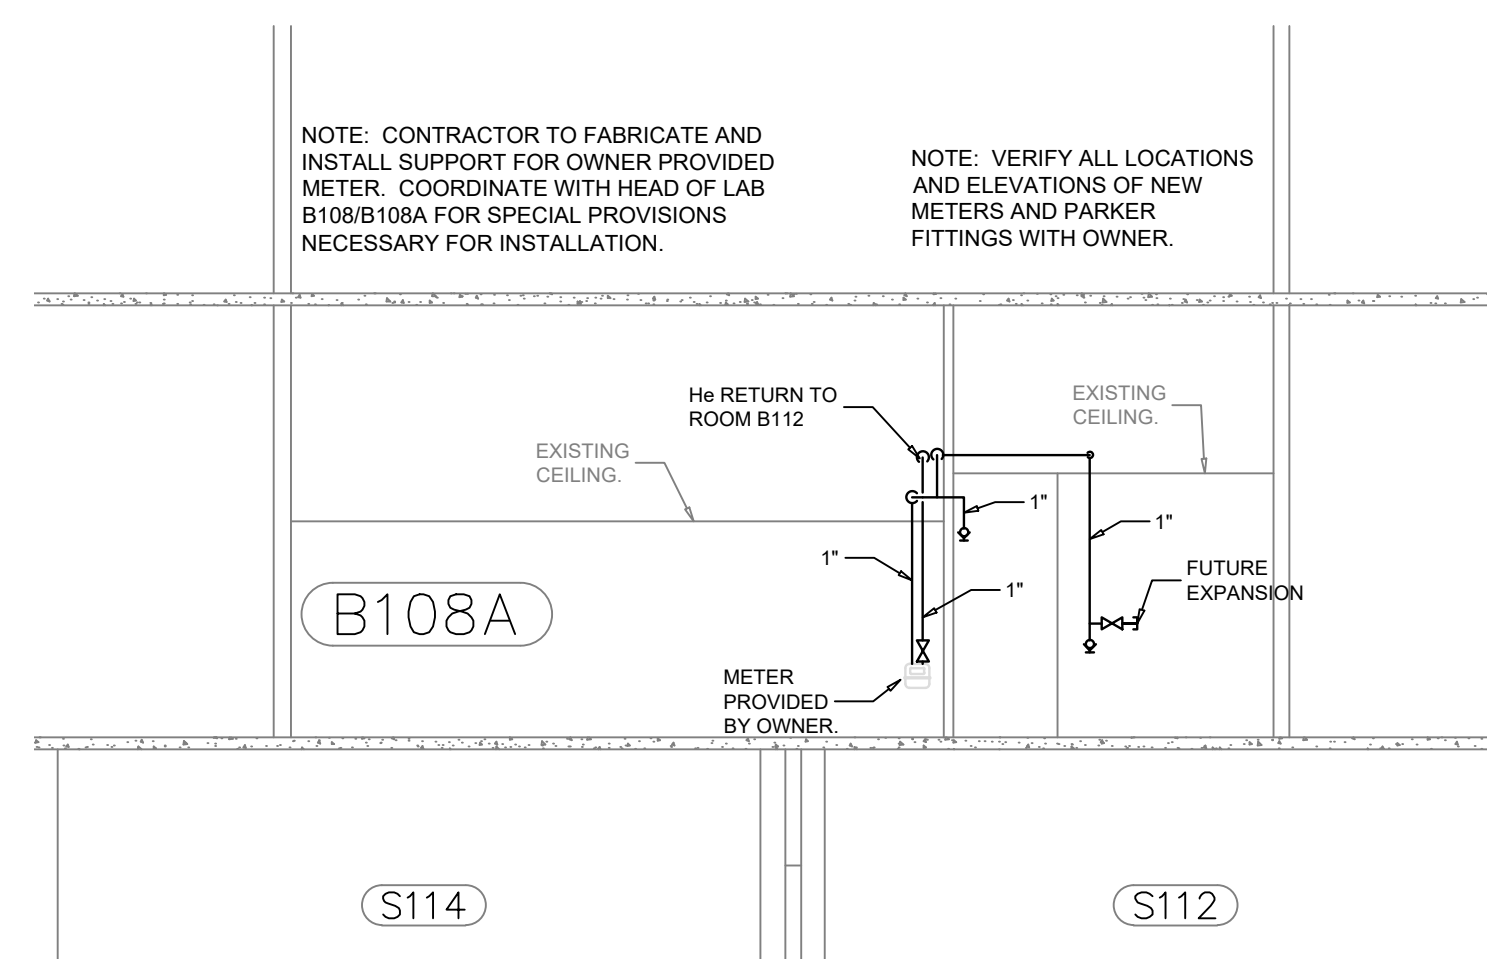

ELEVATION CC
SCALE: 1/8" = 1'-0"

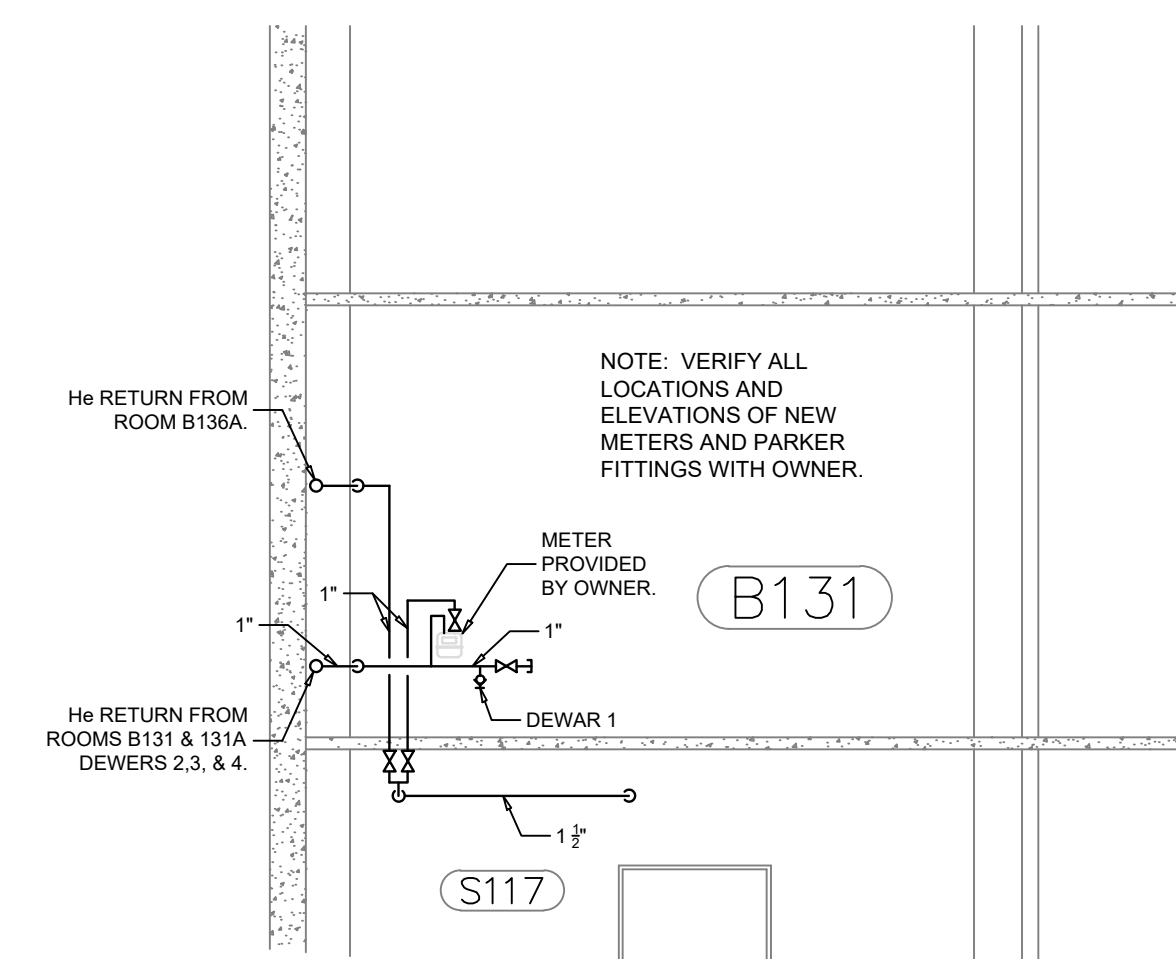

ELEVATION DD
SCALE: 1/8" = 1'-0"

MECHANICAL PLAN NOTES:

1. ALL WORKMANSHIP AND MATERIALS TO FOLLOW MSU STANDARDS OF CONSTRUCTION.
2. ALL PIPE AND FITTINGS TO BE TYPE ACR COPPER WITH BRAZED FITTINGS.

SYMBOLS LIST

- ⊙ PARKER FITTING
- ⊗ ISOLATION VALVE
- ⊔ PIPE CAP OR PLUG

CAPITAL PROJ. NO.
CP

PR. MGR.	O'BRIEN
ARCH.	
MECH.	GOERGE
ELEC.	
CIVIL	
L.A.	
INT. DES.	
CONST. REP.	
APPR.	
DATE	12/5/2019
SCALE	AS NOTED
REVISIONS	